

**NOTES**


GENERAL NOTES :-  
 ALL LEVELS ARE IN METRES RELATED TO AN ASSUMED DATUM LOCATED ON PK NAIL ST01.  
 (value 100.0m).  
 THIS DRAWING HAS BEEN PRODUCED WITH A PLOT SCALE ACCURACY OF 1:50

BUILDING SURVEY KEY :-


- |      |                   |       |                             |
|------|-------------------|-------|-----------------------------|
| (2)  | room height       | hw    | hot water tank              |
| fb   | floor boards      | ic    | inspection cover            |
| Ø    | pipe diameter     | OSM   | ordnance survey bench mark  |
| ab   | air brick         | qt    | quarry tiles                |
| ab   | alarm box         | r     | roof light                  |
| ah   | arch head height  | rw    | rain water pipe             |
| bd   | back drop         | sch   | soil fitted chamber         |
| bk   | brick             | sh    | floor to sill height        |
| conc | concrete          | sp    | arch springing point height |
| cr   | cable tier        | wp    | soil pipe                   |
| dh   | door height       | sus.c | suspended ceiling           |
| dh   | door height       | wp    | not vent pipe               |
| dh   | door height       | L     | level - heated lower rail   |
| dh   | door height       | TBM   | temporary bench mark        |
| elec | electricity metre | z     | finish level                |
| fp   | fire place        | top   | top of clip                 |
| fl   | floor level       | top   | top of pipe                 |
| fl   | floor level       | ub    | top of tank                 |
| fl   | floor level       | uh    | underside height            |
| fl   | floor level       | UTL   | unable to lift              |
| fl   | floor level       | wp    | waste pipe                  |
| fl   | floor level       | wf    | water fountain              |
| fl   | floor level       | wf    | water filled chamber        |
| fl   | floor level       | wp    | waste pipe                  |

SERVICES KEY :-


- |     |                                |      |                          |
|-----|--------------------------------|------|--------------------------|
| — — | strip light                    | ⌂    | alarm keypad             |
| ⊗   | light                          | ⌂    | intercom                 |
| ⊕   | wall light                     | ACP  | alarm control panel      |
| EM  | emergency light                | SPK  | speaker                  |
| ⊙   | spot light                     | PROJ | projector                |
| ⊙   | pull cord                      | CCTV | closed circuit tv        |
| V   | vent/extractor                 | S    | sensor                   |
| BW  | switch                         | NC   | network point            |
| LS  | light switch                   | TV   | coaxial aerial           |
| FS  | fused switch                   | ⊕    | heat detector            |
| ISO | isolator switch                | ⊕    | smoke detector           |
| C   | cooker switch                  | ⊕    | fire alarm siren         |
| F   | fuse                           | ⊕    | fire breakglass          |
| B   | blank socket                   | ⊕    | fire sprinkler           |
| ⊕   | single socket                  | ⊕    | fire blanket             |
| ⊕   | double socket                  | ⊕    | water fire extinguisher  |
| ⊕   | ceiling socket/fuse/switch     | ⊕    | co2 fire extinguisher    |
| ⊕   | thermostat                     | ⊕    | powder fire extinguisher |
| ⊕   | card access point (swipe card) | ⊕    | fire extinguisher        |
| ⊕   | emergency door release         | FAP  | fire alarm control panel |

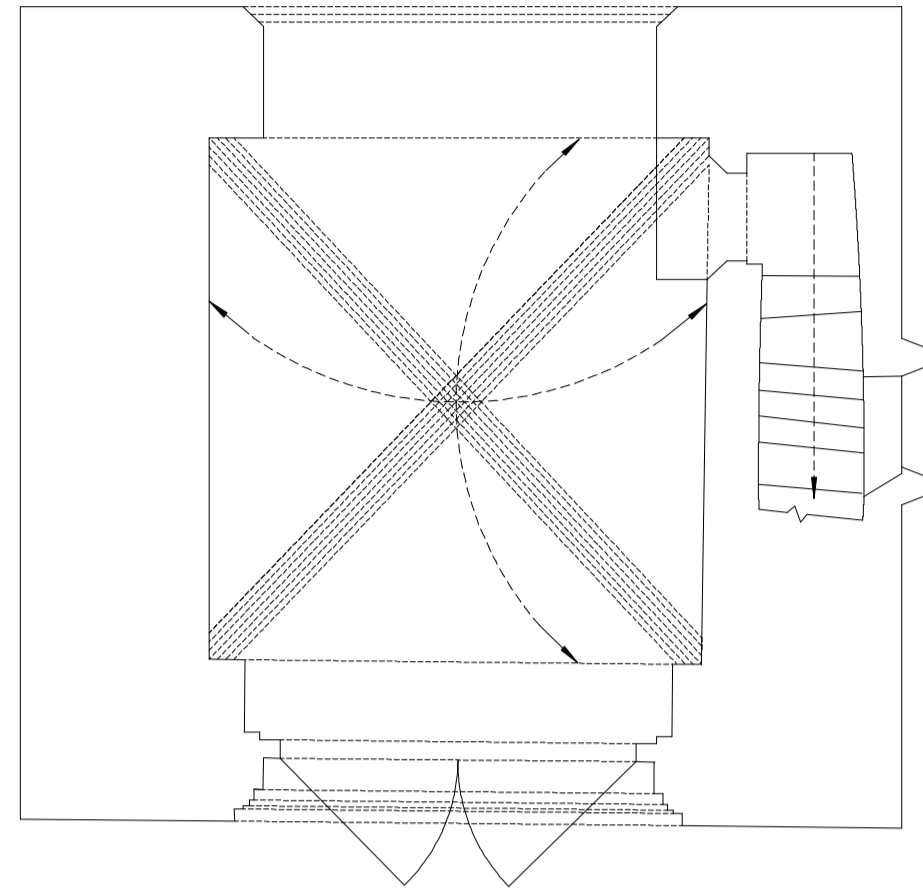

GROUND FLOOR PLAN

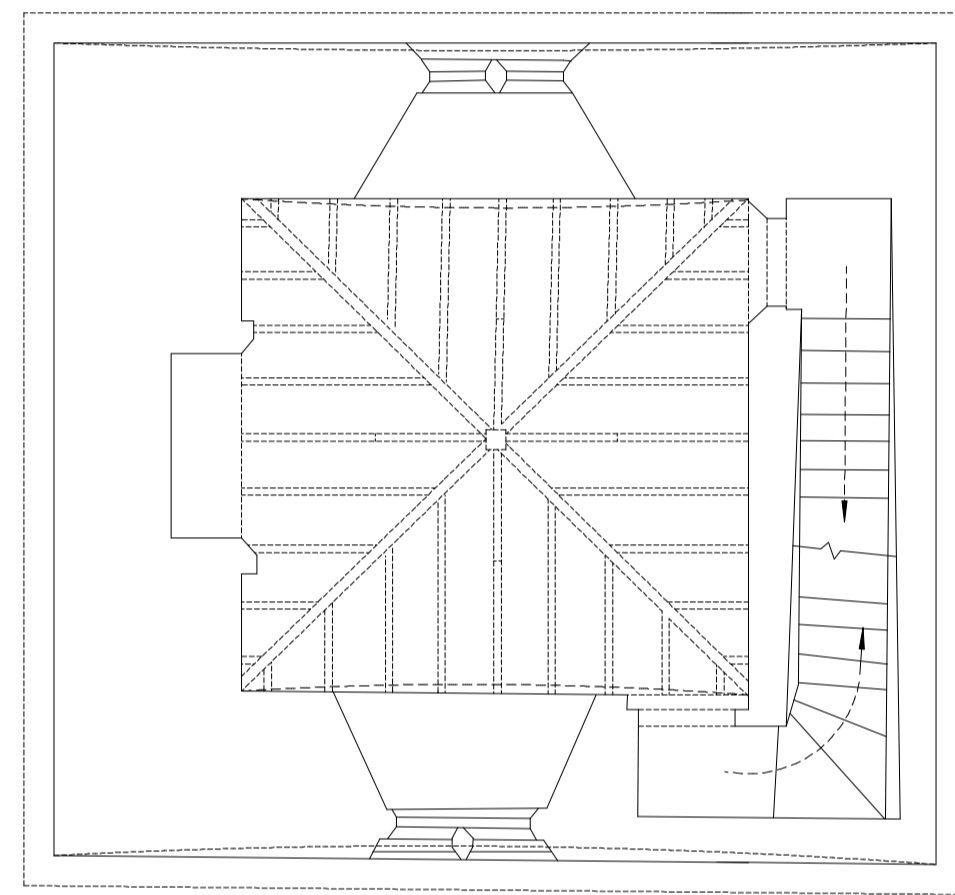

FIRST FLOOR PLAN

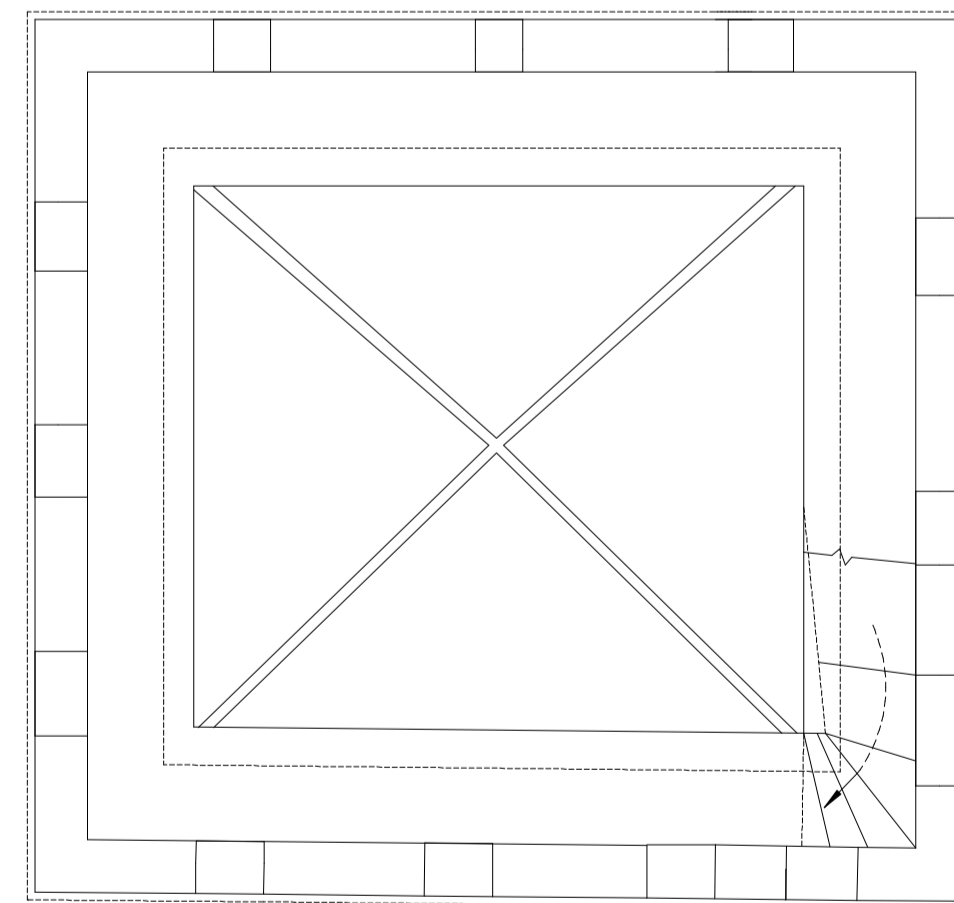

ROOF FLOOR PLAN

NORTH POINT :-

SHEET LAYOUT :-



**MIDLAND SURVEY LTD**

HEAD OFFICE:  
 Cornwell House, Westfield Road, Southam, Warwickshire, CV47 0JH.  
 Tel: 01205 810811 Fax 01205 810812  
 E-Mail: mail@midlandsurvey.co.uk  
 www.midlandsurvey.co.uk

Client: GRAHAM FRECKNALL ARCHITECTURE & DESIGN

Project: GREAT PORTHAMEL GATE HOUSE

Title: FLOOR PLANS

Date: JAN 2019 Revisions:

Scale: 1:50@A1

Dwg No: 32820A R1 1

Surveyor: ML

Checked: MW

**TOPOGRAPHICAL (LAND) SURVEYORS / UTILITY SURVEYORS  
 BUILDING MEASUREMENT SURVEYORS / 3D LASER SCANNING**

